




RECONSTRUCTION OF CONSERVATORY GARDEN
ENGLISH GARDEN
PROPOSED GRADING (DRAFT)

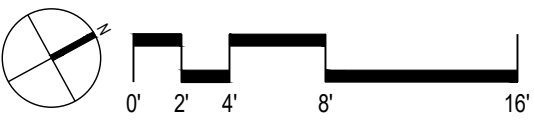

SCALE: DATE: 08/28/2020

- PROPOSED TRENCH DRAIN
- PROPOSED STORM SEWER
- PROPOSED UNDERDRAIN
- PROPOSED STORM MANHOLE
- PROPOSED CATCH BASIN

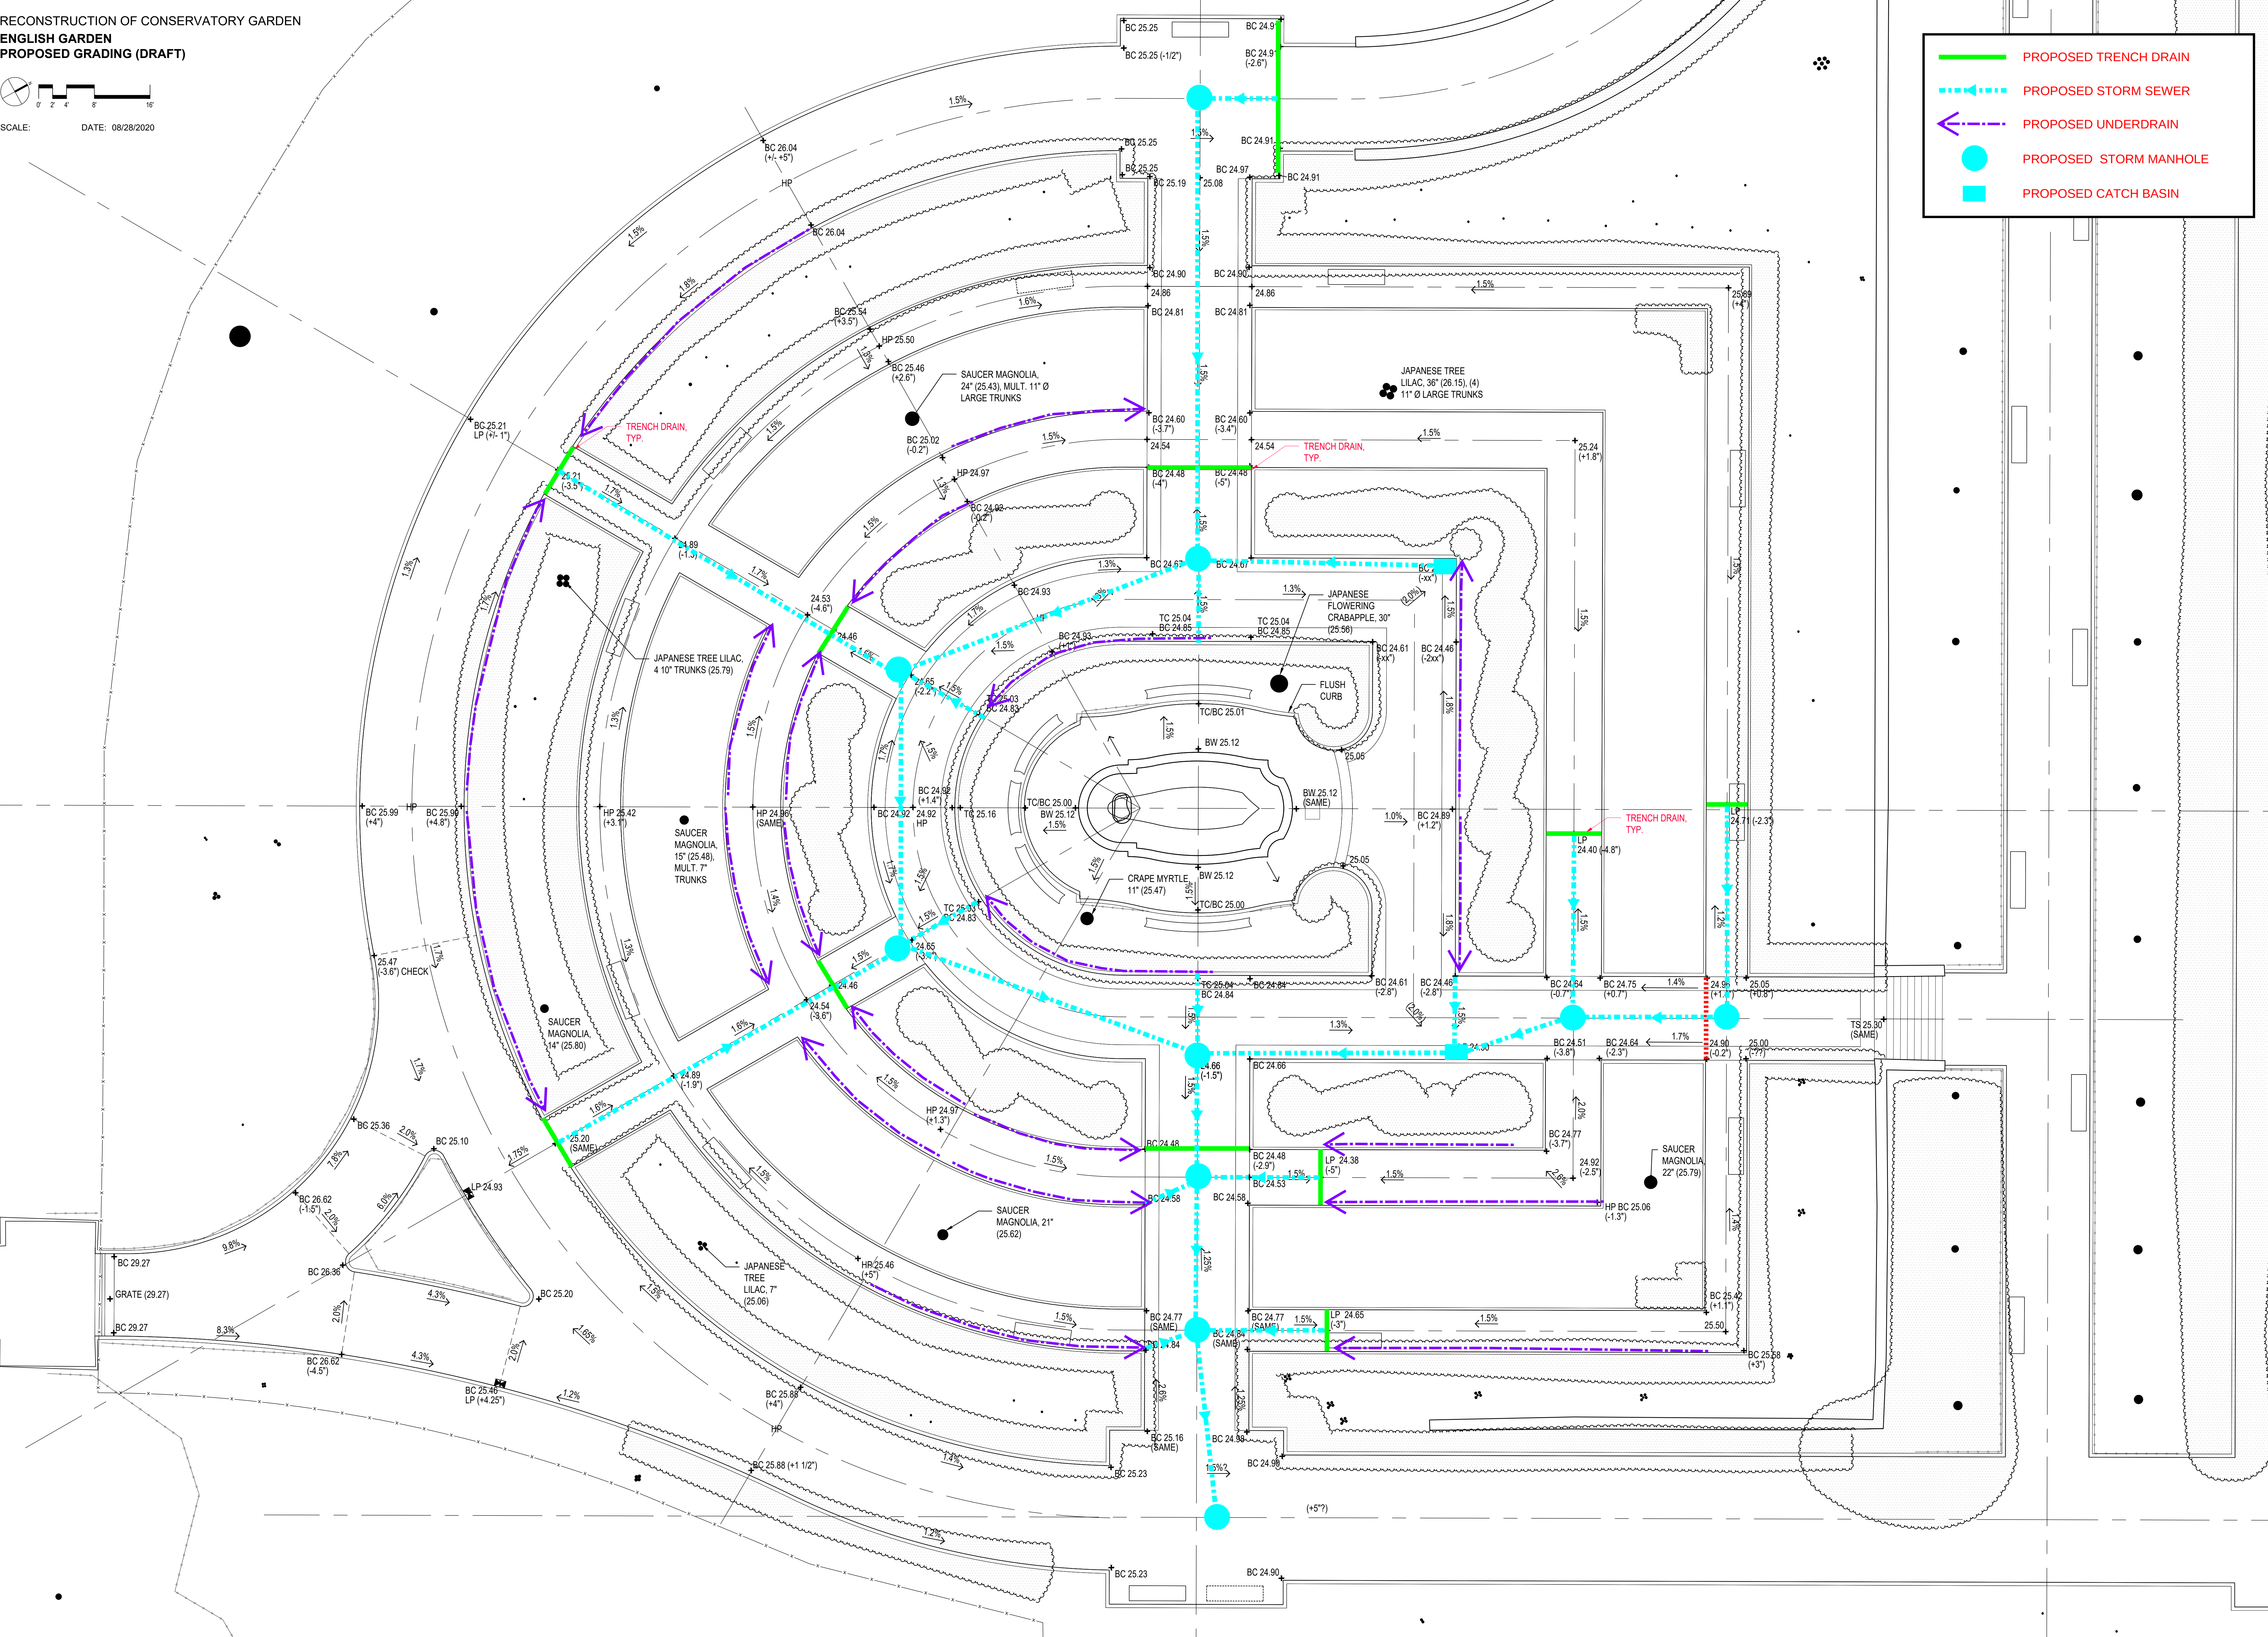

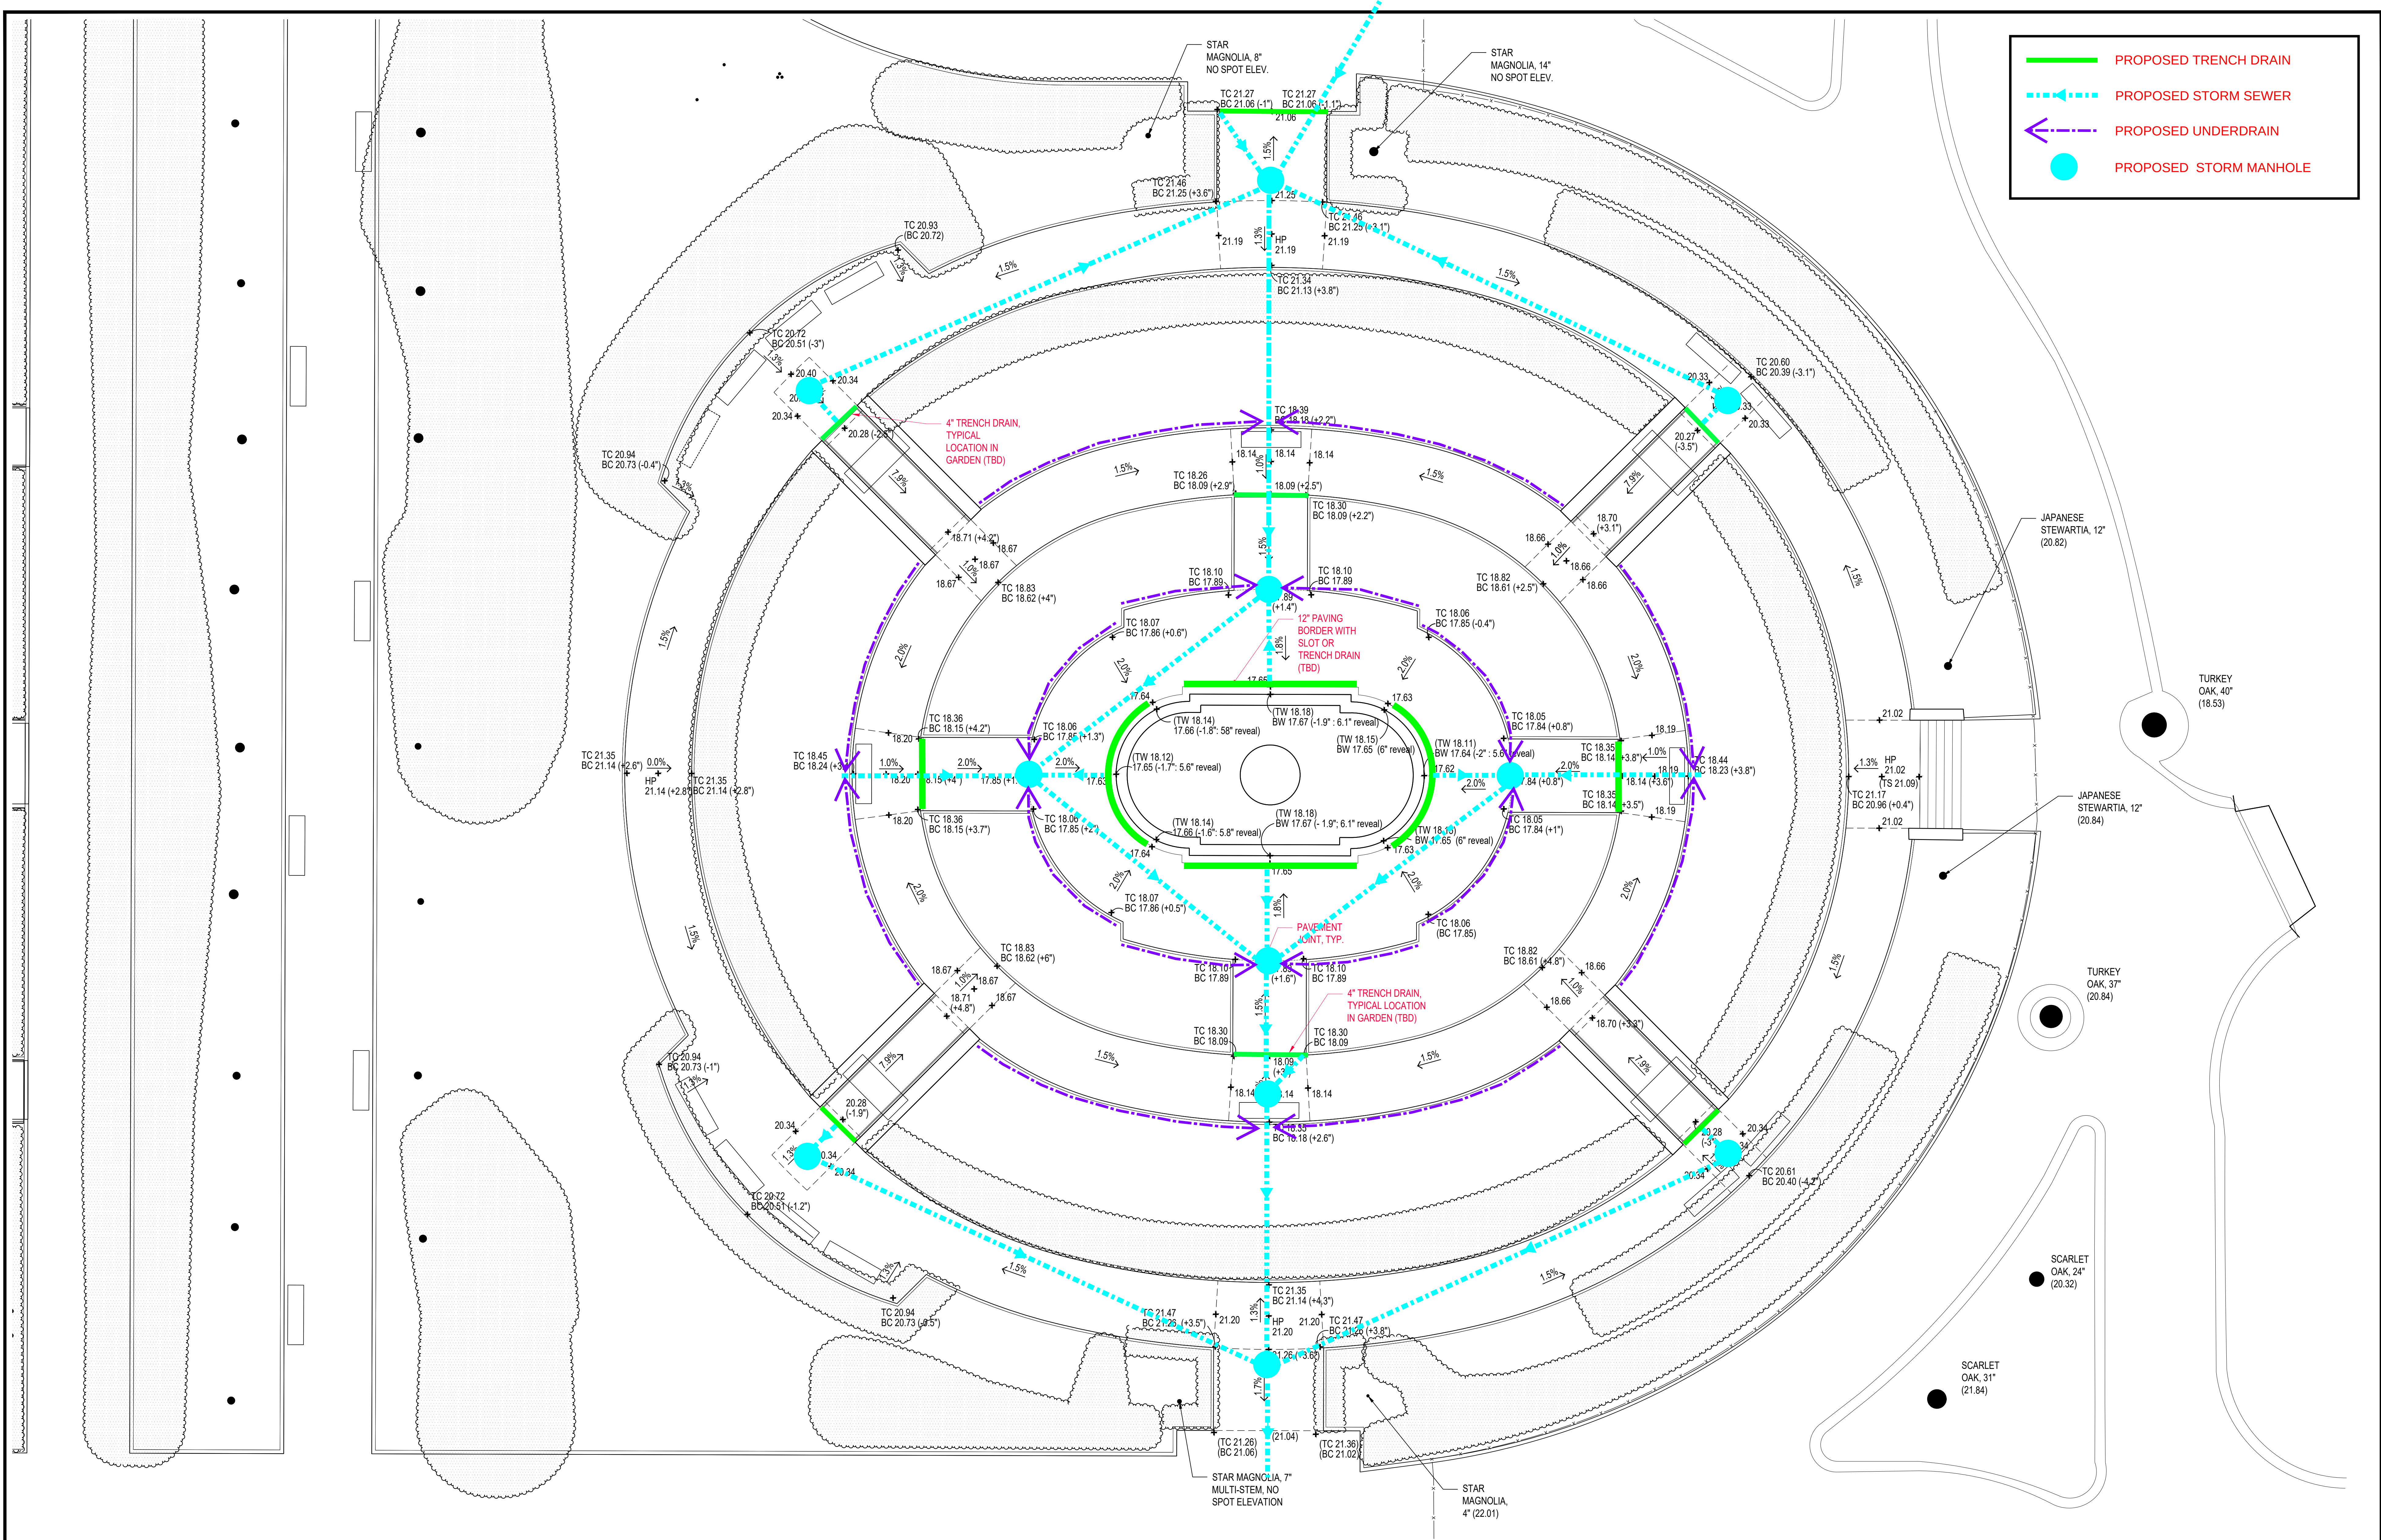

PROPOSED TRENCH DRAIN

PROPOSED STORM SEWER

PROPOSED UNDERDRAIN

PROPOSED STORM MANHOLE

Structural + Civil Engineer

STANTEC

475 Fifth Avenue, 12th Floor
New York, NY 10017
Tel: 646-400-3796
www.stantec.com

MEP Engineer

IP GROUP

648 Broadway, No. 400
New York, NY 10012
Tel: 212-982-3877
www.ipgroupllc.com

Irrigation

IRRIGATION CONSULTING, INC.

20 Merritt Parkway, Second Floor
Nashua, NH 03062
Tel: 978-433-8972 Ext. 11
www.irrigationconsulting.com

Fountain Design

FLUIDITY DESIGN CONSULTANTS

3780 Wilshire Blvd., Suite 230
Los Angeles, CA 90010
Tel: 310-567-5153
www.fluidity-design.com

Owner/Landscape Architect

CENTRAL PARK CONSERVANCY

14 East 60th Street
New York, NY 10022
Tel: 646-457-9220
www.centralparknyc.org

NOT FOR CONSTRUCTION

REV.

DESCRIPTION

DATE

No.

ISSUE NAME

DATE

RECONSTRUCTION OF CONSERVATORY GARDEN

CP17002.CGARDN

DRAWING TITLE

FRENCH GARDEN

PROPOSED GRADING

0' 2' 4' 8' 16'

SCALE:

DRAWN: PDC

CHECKED: BR

APPROVED: CN

DATE: 07/15/2020

DRAWING No.

L-100

SHEET No. XX OF XX

Drawing Name: Q:\CP17002.CGARDN\DRAWINGS\G-1_GRADING PLAN.dwg + Date Saved: Jul 15, 2020, 2:43pm + Xref's Attached: X-CG_STAND_SURVEY; X-BASE; X-TBlock-30x42 + Printed By: ekushner + Layout: 30x42 FRENCH GARDE - EIGHTH SCALE-PROPOSED