


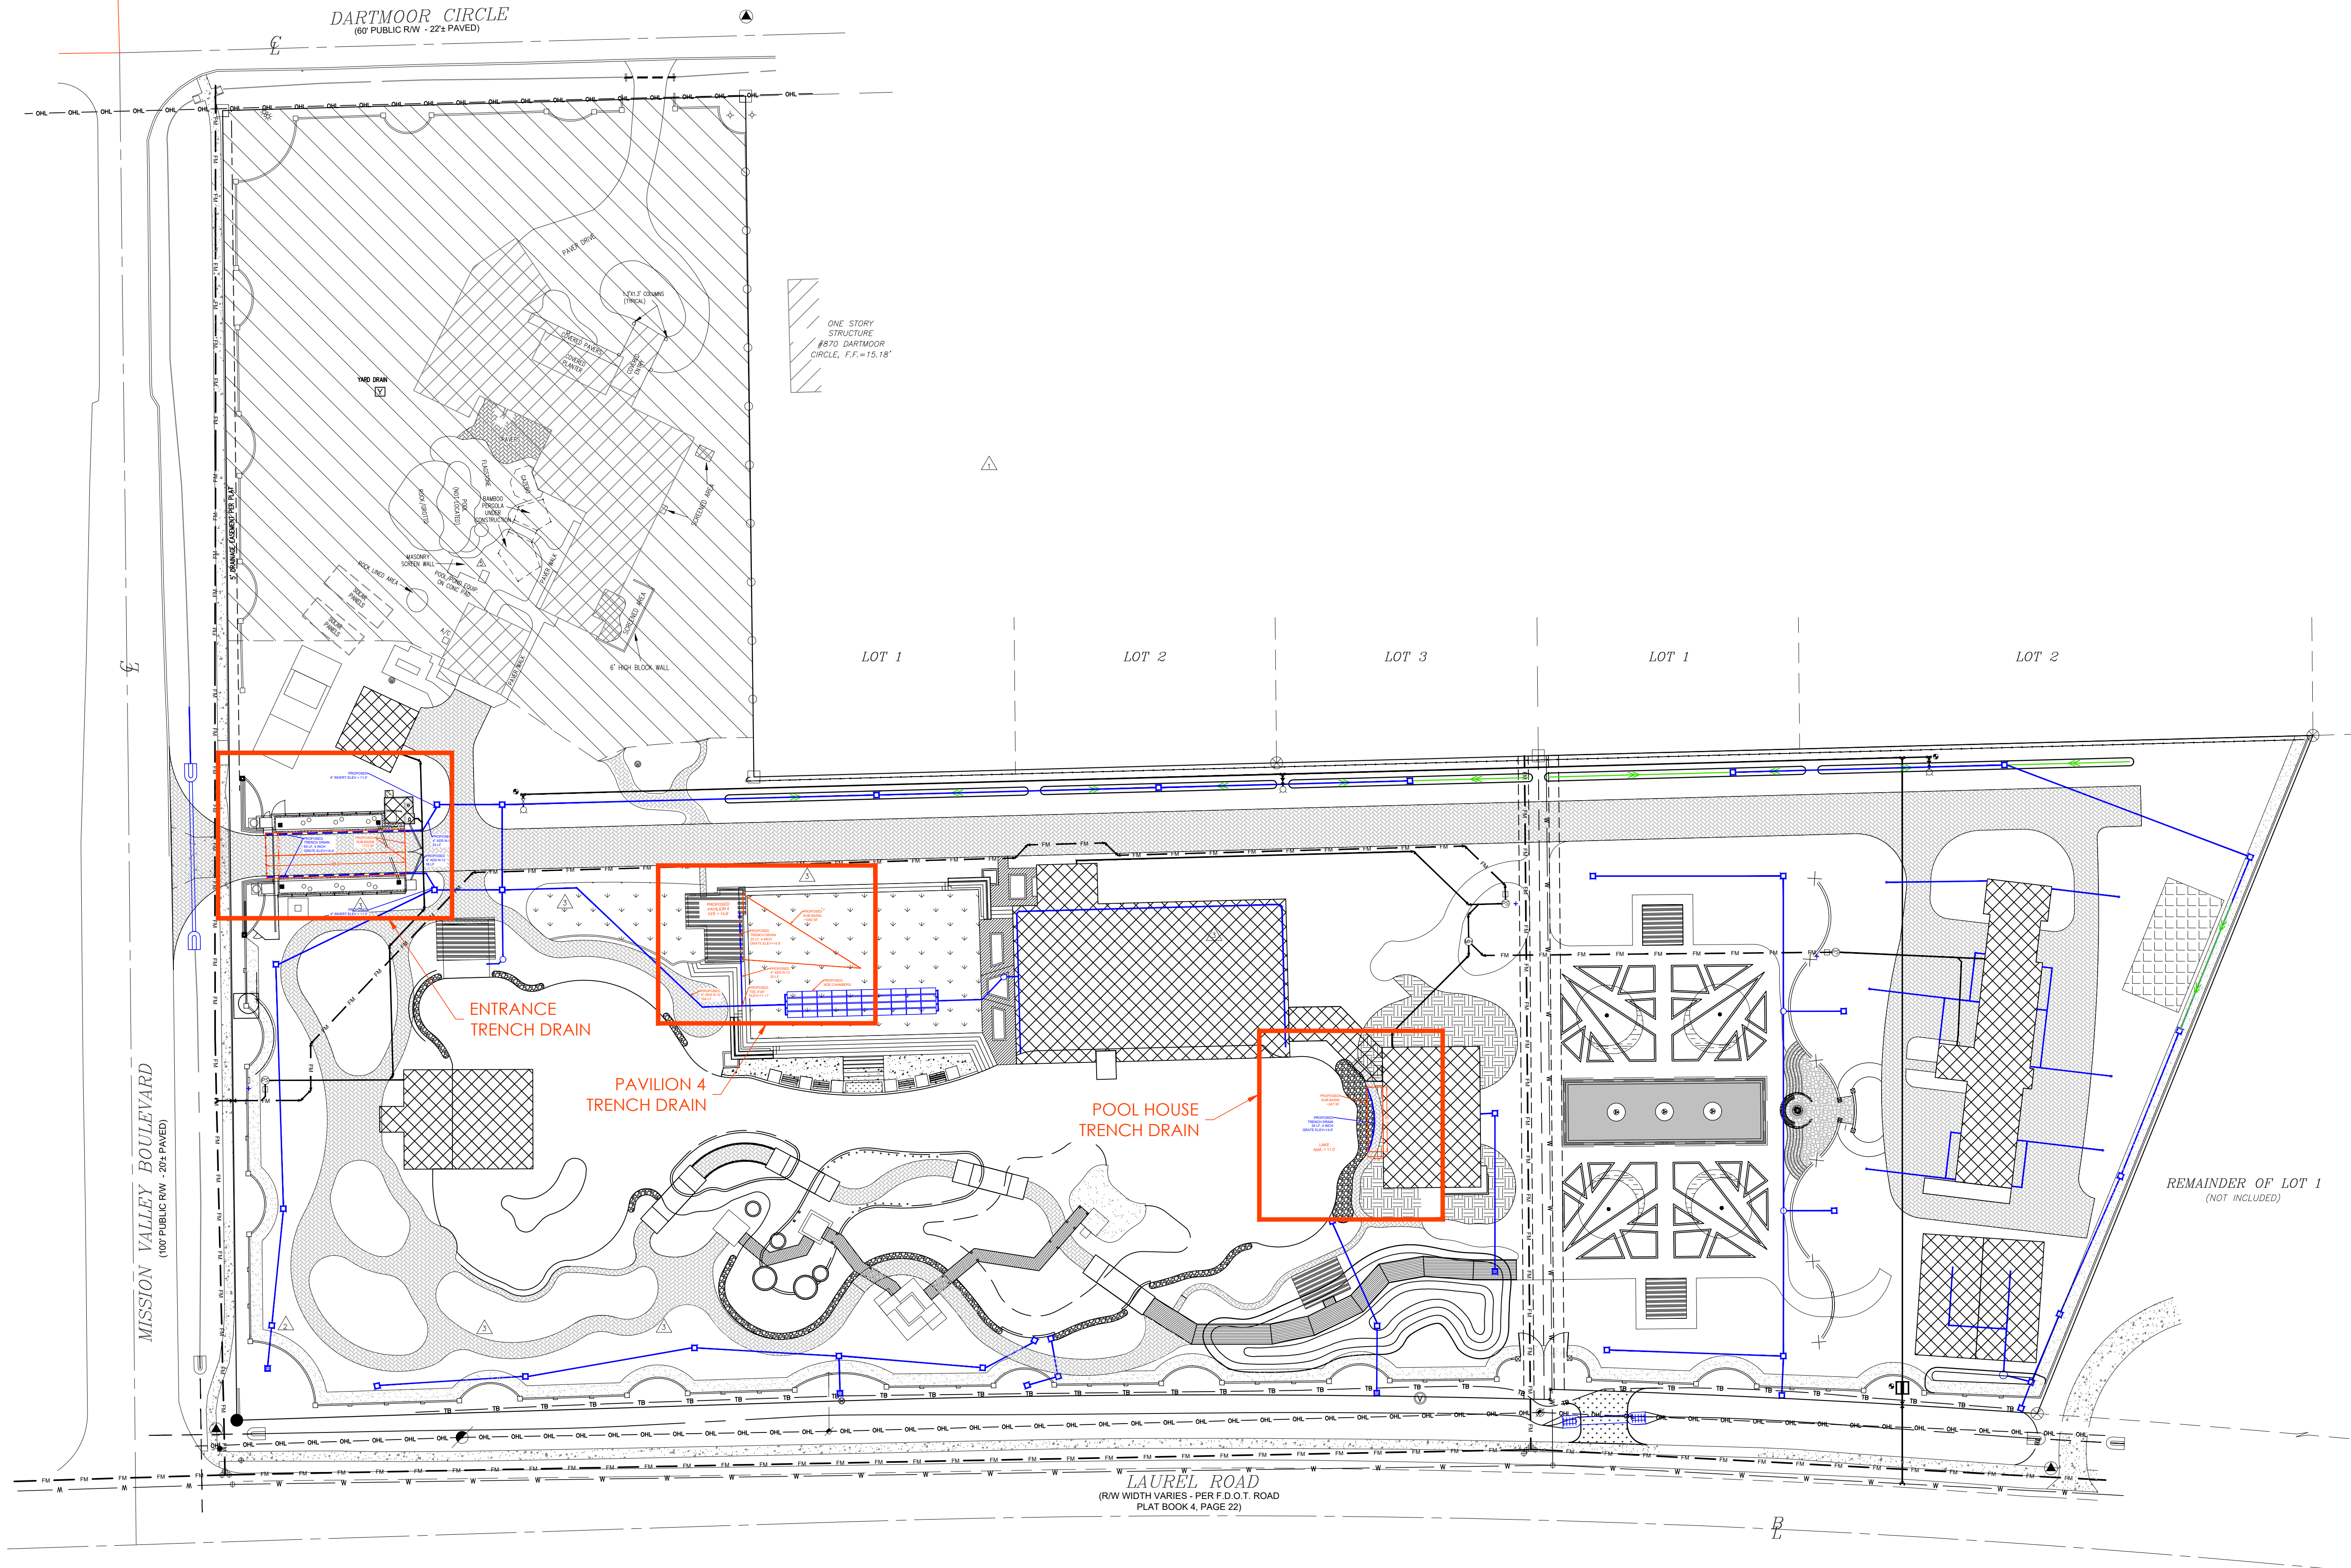

**Marsabel**  
ENGINEERING & INSPECTION SERVICES

PROJECT: HEINSCRAFT GARDENS  
SITE DRAINAGE PLANS  
800 MISSION VALLEY BLVD.  
NOKOMIS, FL 34275

| Δ/REV NO. & DATE | REVISION                                              |
|------------------|-------------------------------------------------------|
| 1 3/27/19        | ADDED NOTE 12 PER COMMENTS                            |
| 2 4/16/19        | REVISED STRUCTURE S-112A SYMBOL                       |
| 3 xx             | REV BASINS 100 & 200 AND SUB-BASINS 106, 109, AND 110 |

TITLE: DRAINAGE PLAN  
OVERALL

SONYA G. FRONCKOWIAK, P.E.  
FLORIDA LICENSE NO. 65736  
CA NO.: 28519

DATE: 3/6/2019

JOB NO.: SHEET NO.: 6